

**GENERAL NOTES:**

1. (N) CEILING HEIGHT AS NOTED ON PLAN
2. NOT USED
3. NOT USED
4. SEE DETAIL 9/AI-509 FOR TYPICAL FUME HOOD CLOSURE AT SUSPENDED CEILING.
5. NOT USED
6. ALL SPRINKLER HEADS ARE TO BE CENTERED IN CEILING TILE LION.

**NUMBERED SHEET NOTES:**

- 1 NEW PIPE DROP ENCLOSURE THROUGH CEILING


**Gicklhorn Lazzarotto Partners**

645 HARRISON ST  
SUITE 101  
SAN FRANCISCO  
CA 94107  
415 512 7396  
415 512 7398  
GLP.com

**CONSULTANTS**

**MECHANICAL/ELECTRICAL/  
PLUMBING ENGINEER**  
GANNER ENGINEERS  
1133 POST STREET  
SAN FRANCISCO, CA 94109  
SAN FRANCISCO, CA  
TEL: 415.474.1353  
FAX: 415.474.1353

**KEY PLAN:**

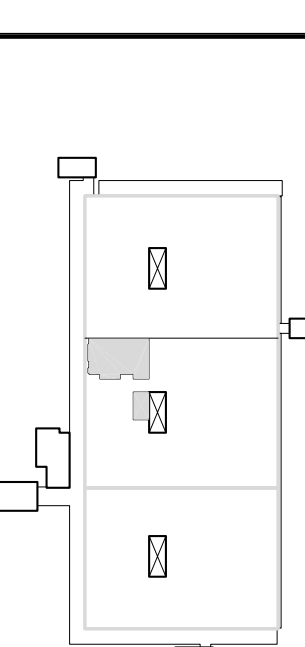

FIRE MARSHAL:

DSA:



**University of California**  
Physical Planning and Construction  
Santa Cruz Campus  
Santa Cruz, California  
**Baskin Alterations - Labs 206, 207  
& 208 Final User Build-out**  
Baskin Engineering Building  
1156 High Street  
Santa Cruz, CA 95064  
USGC PROJECT & FILE NO: 2700-111  
ISSUE DATE

NO.	DATE	REVISIONS DESCRIPTION

PROJECT NO:	0723
CAD DWG FILE:	A-FA12.DWG/GD011.B.DWG
DRAWN BY:	FA/CH/ZK
CHECKED BY:	MHG
SHEET TITLE:	

**SECOND FLOOR  
REFLECTED CEILING PLAN  
NEW CONDITION (CENTER)**


**AL-412.2**  
OF



1

A-FA12-DWG

SECOND FLOOR REFLECTED CEILING PLAN (FOR REFERENCE ONLY)  
1/8"=1'-0"

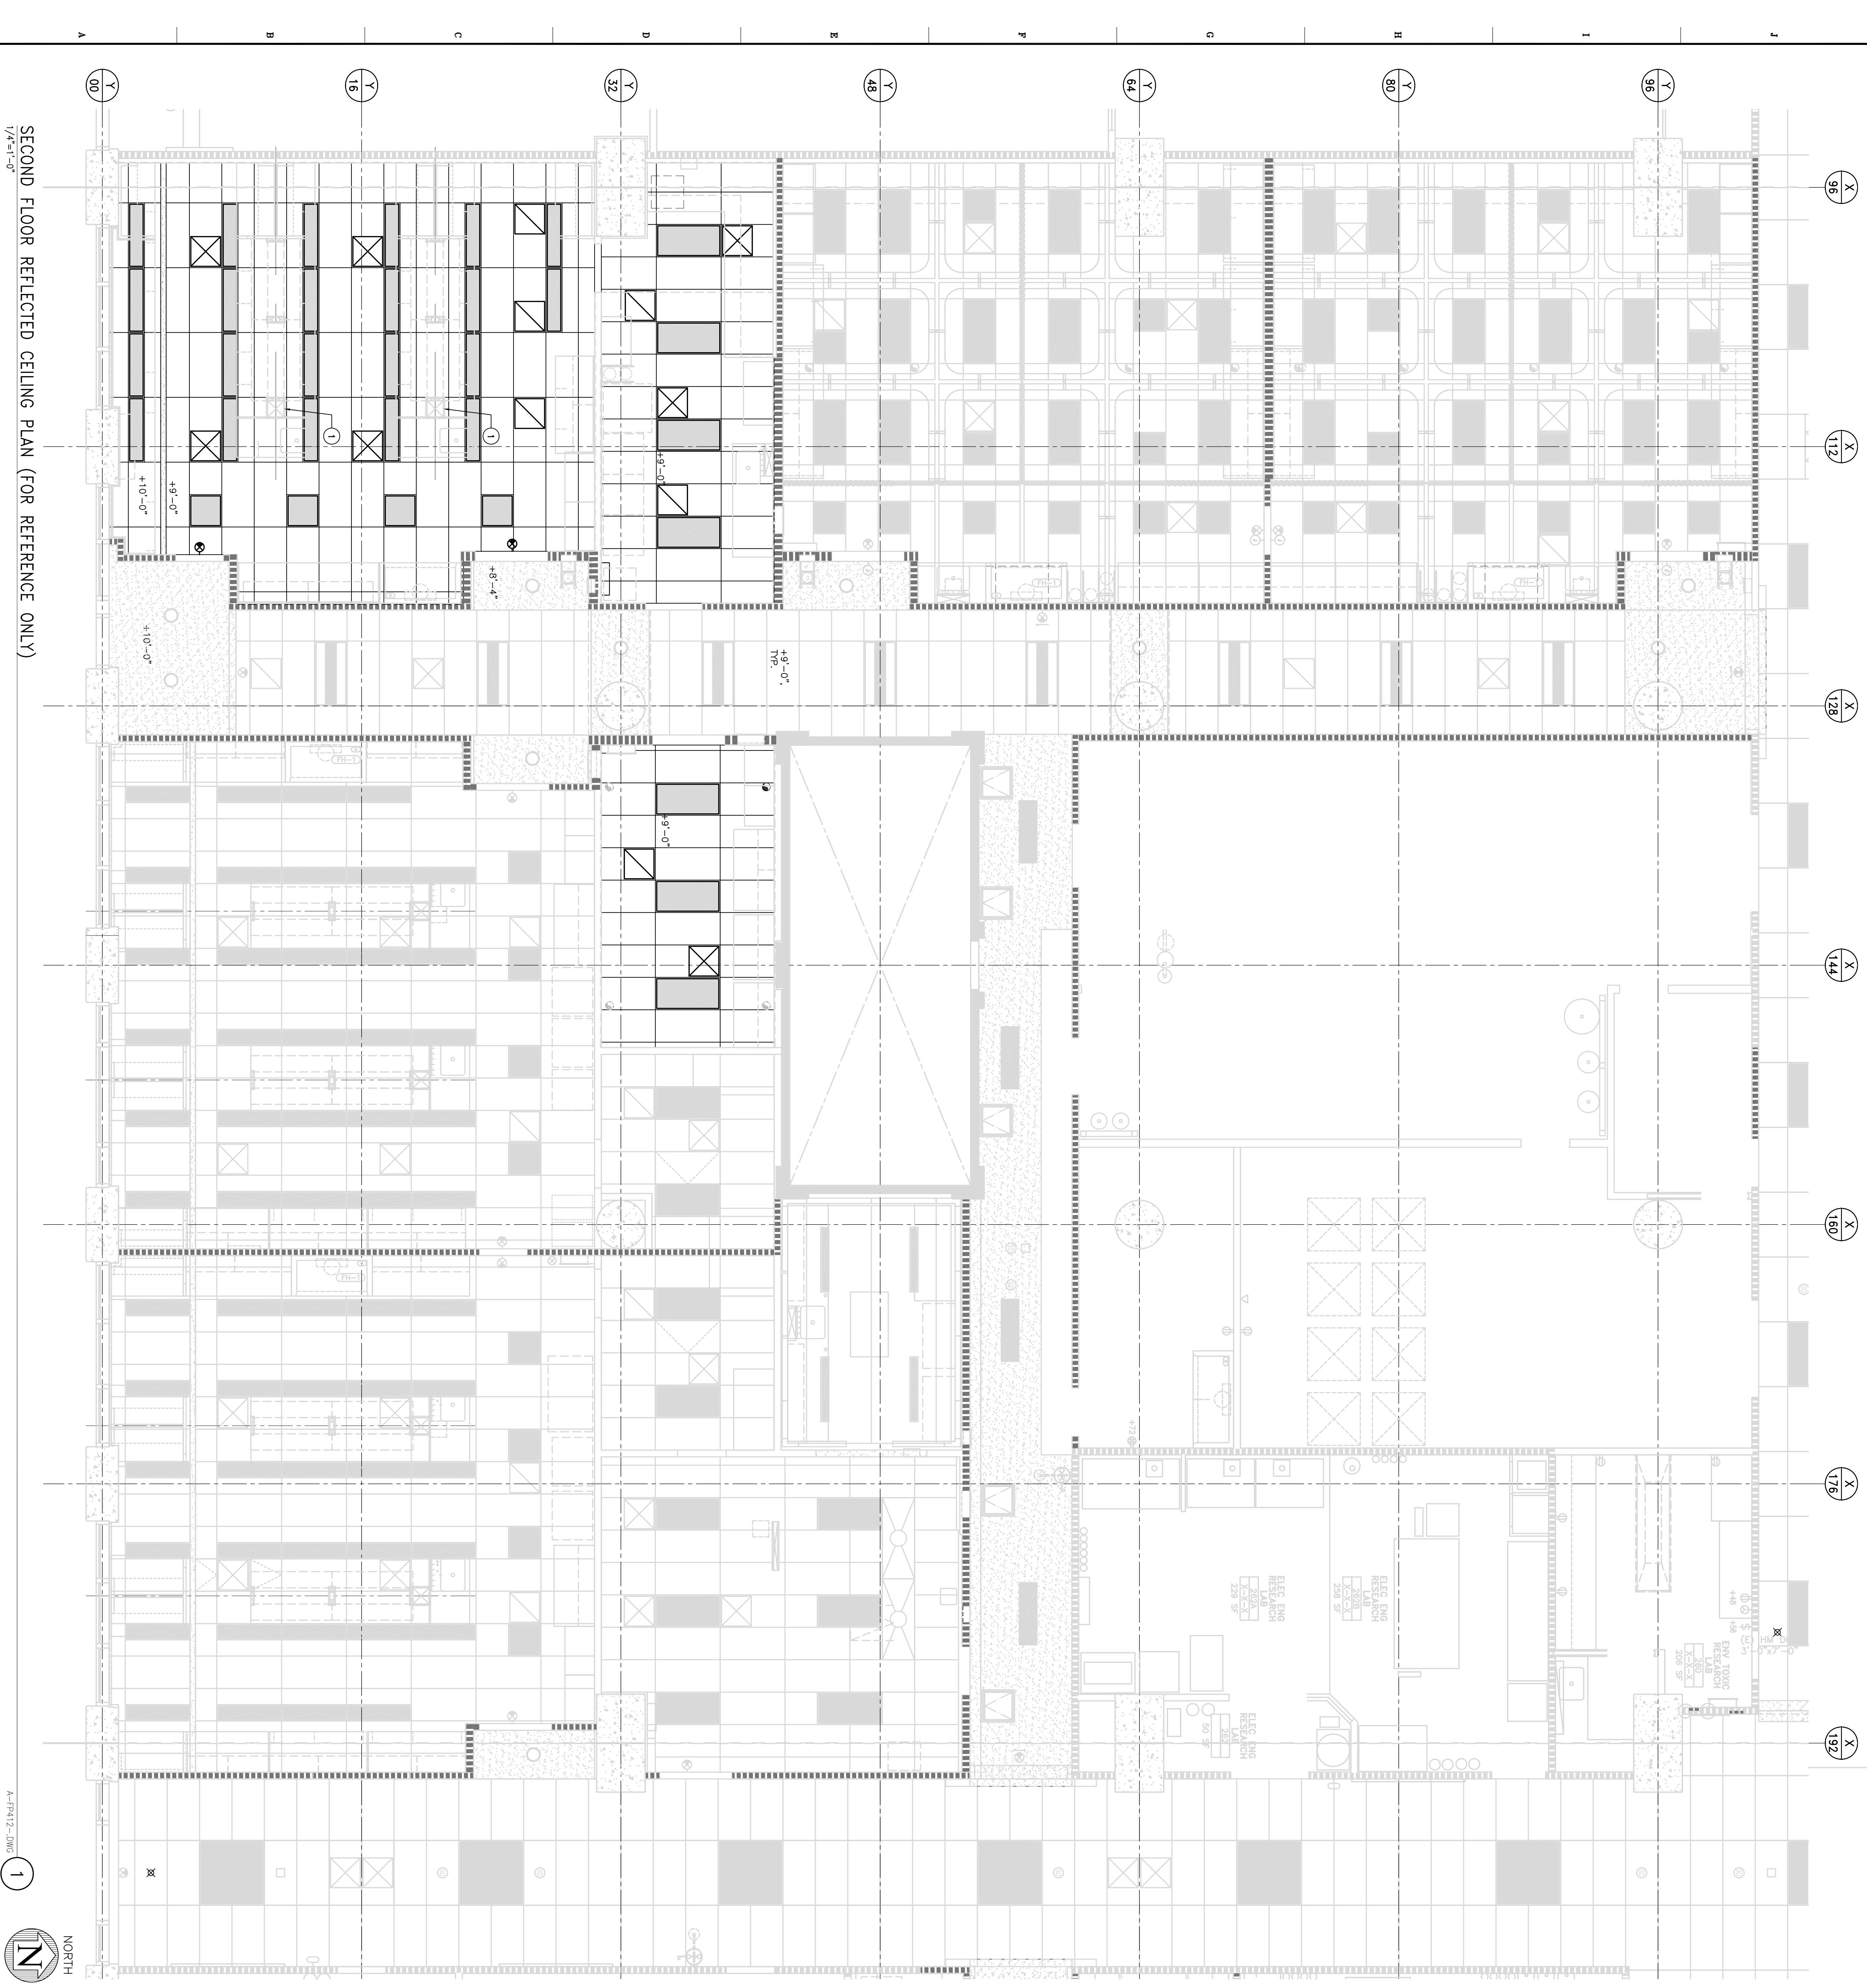

**SYMBOLS LEGEND:**

- EXISTING NON-RATED PARTITION
- EXISTING 1-HR PARTITION
- EXISTING 2-HR PARTITION
- GYPSUM BOARD CEILING
- 2x4 RECESSED FLUORESCENT LIGHT FIXTURE
- 2x4 SPECIAL FLUORESCENT LIGHT FIXTURE
- 2x2 FLUORESCENT LIGHT FIXTURE
- 4x4 FLUORESCENT LIGHT FIXTURE
- RECESSED FLUORESCENT DOWNLIGHT FIXTURE
- RECESSED WALL WASHER (DIRECTIONAL)
- FIRE SPRINKLER
- SMOKE DETECTOR
- WALL MOUNTED EXIT LIGHT
- CEILING MOUNTED EXIT LIGHT
- 2x2 SUPPLY AIR REGISTER - SEE MECHANICAL DWGS.
- 2x2 EXHAUST - SEE MECHANICAL DWGS.
- 48"x6" SUPPLY AIR REGISTER - SEE MECHANICAL DWGS.
- 48"x6" EXHAUST - SEE MECHANICAL DWGS.
- ACCESS PANEL
- INDICATES CENTERPOINT OF CEILING GRID IN THE SPACE. CENTER CEILING PANEL, LIGHT OR GRID SECTION, ON WHICH SYMBOL IS INDICATED IN SPACE